


DEPARTMENT OF THE AIR FORCE
 DIRECTORATE OF ENGINEERING & SERVICES DCSAEE-WASHINGTON DC
 UNITED STATES AIR FORCES IN EUROPE
 RAF BENTWATERS
 BUILDINGS 1603,
 & 1605-1617
 FLOOR PLAN
 SCALE: 1/8" = 1'-0"
 DATE: 15 NOV 92
 DRAWING NUMBER
 DRAWN BY: N.J.F.
 REV. DATE:
 DL ST CIVIL ENGINEERING SQUADRON
 RAF BENTWATERS, SUTTOR, ENGLAND
 SHEET 1 OF 1

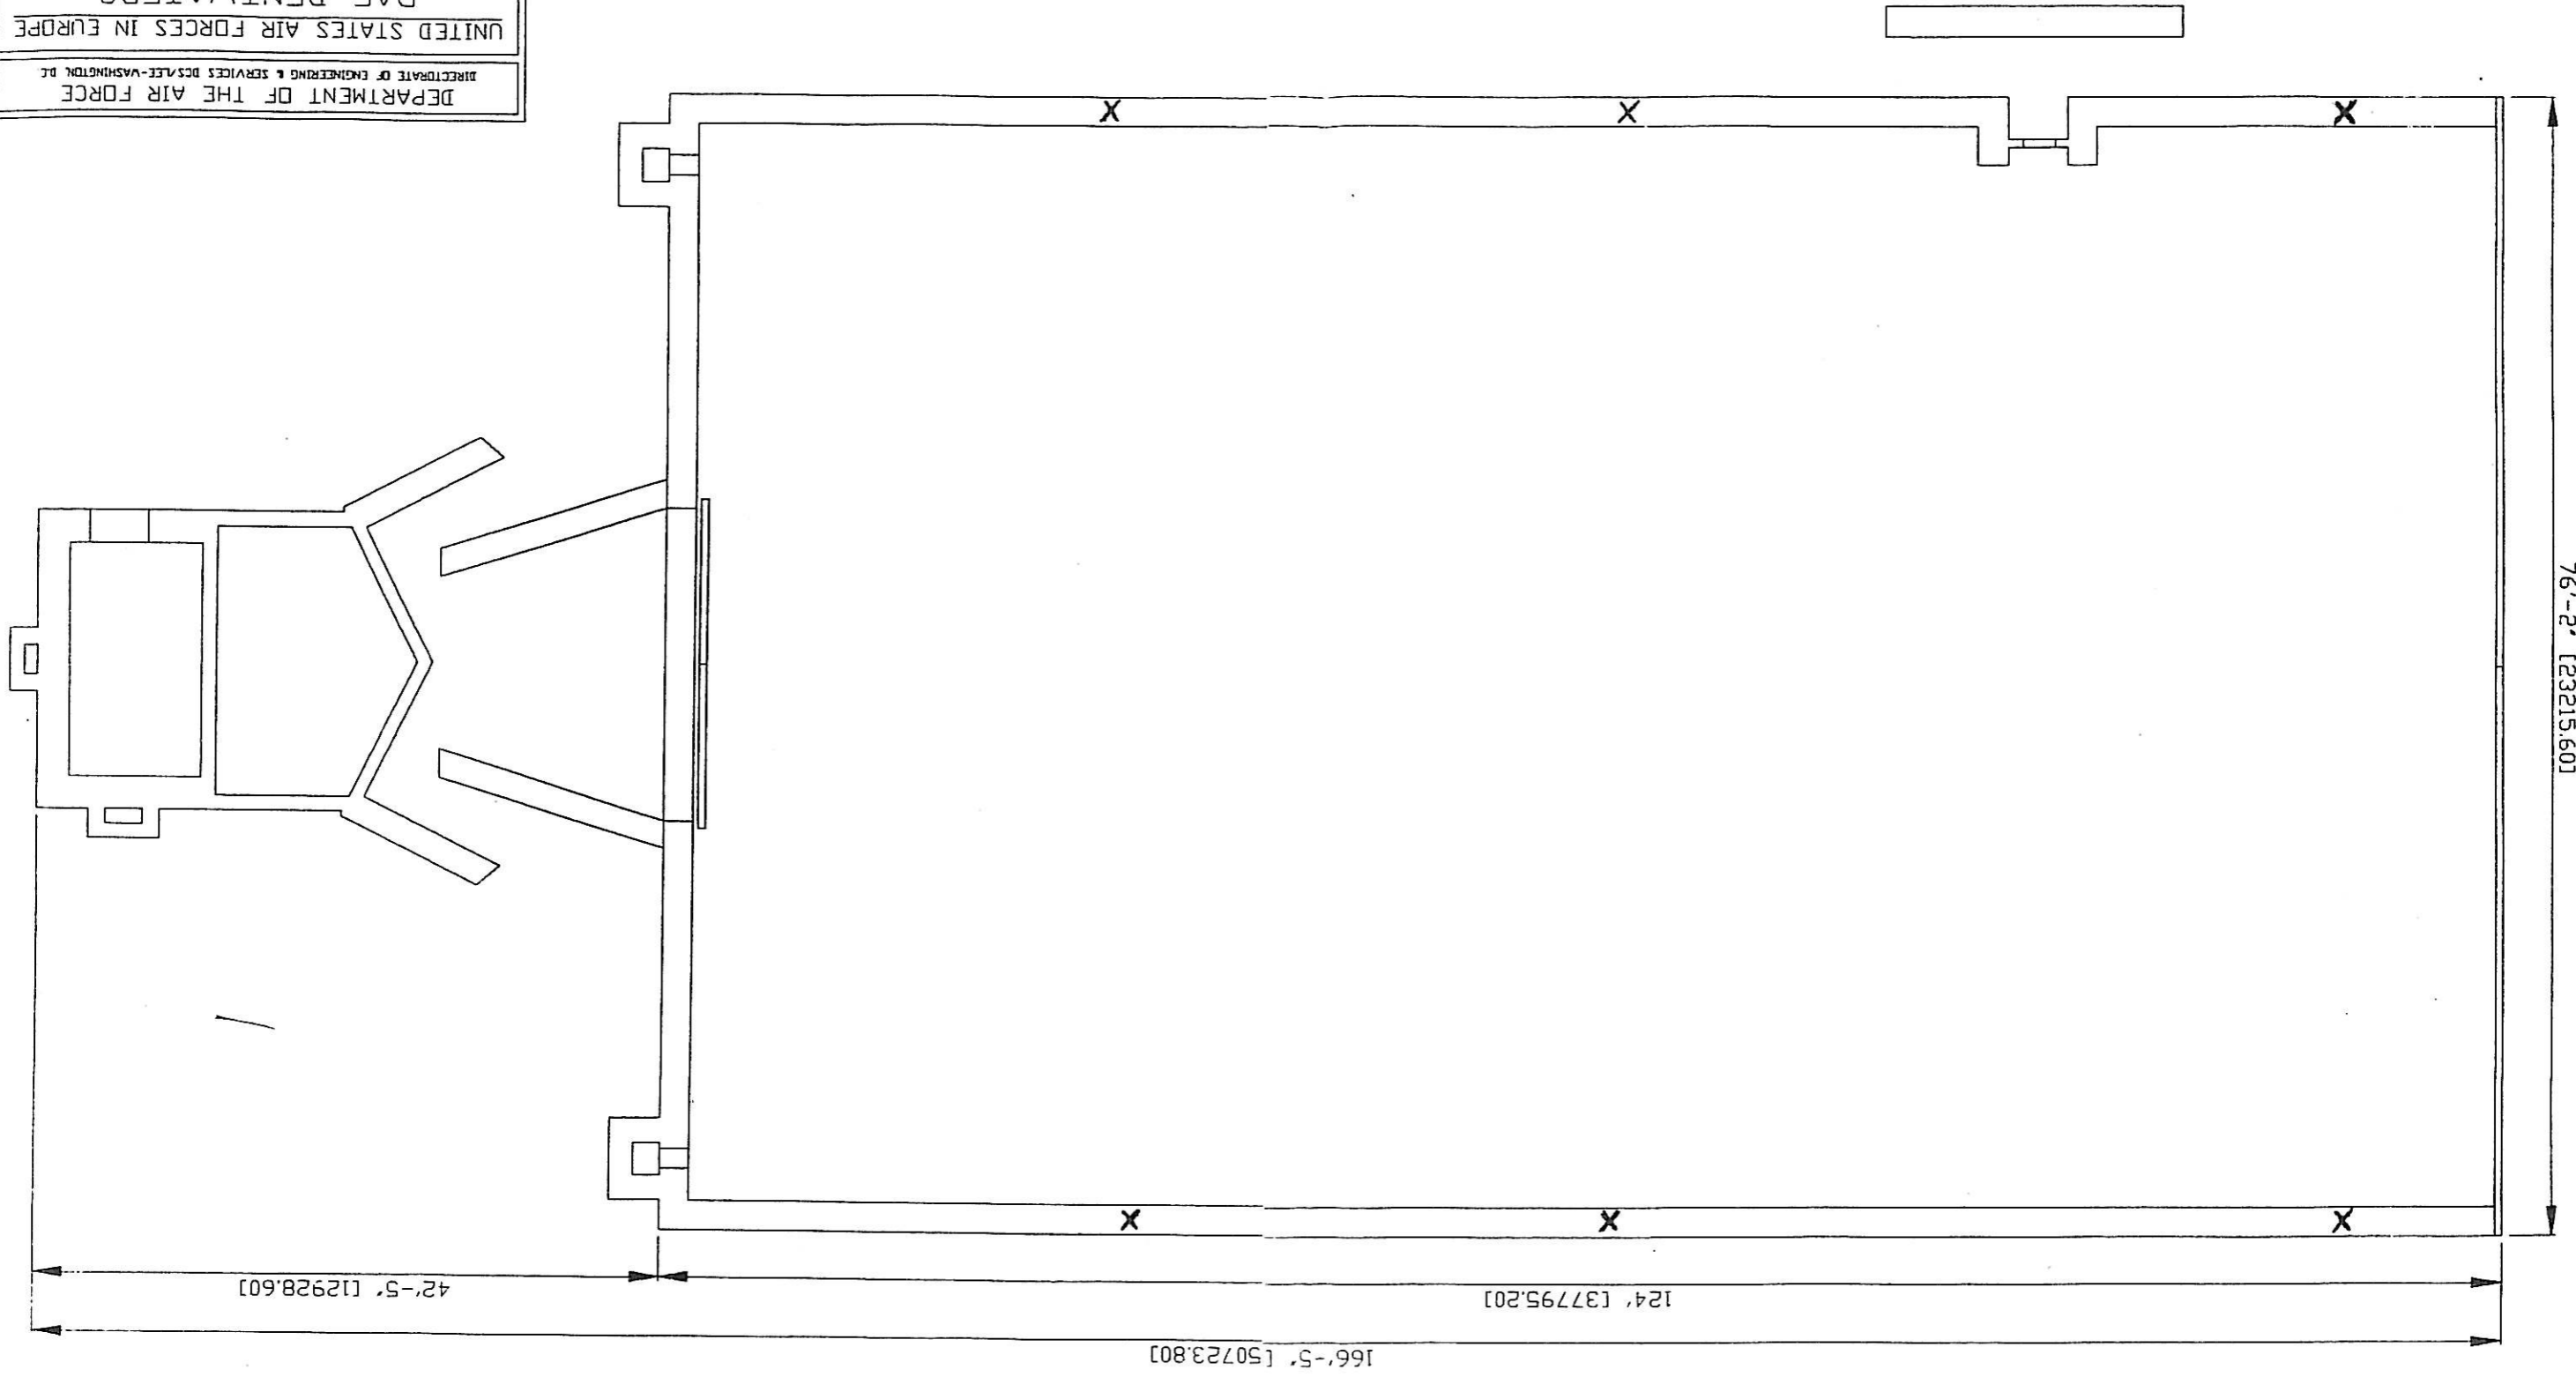

HEIGHT AT APEX 36' INTERNAL MEASUREMENT
 X = 240V ELEC. POINT (SINGLE)

76'-2" [23215.60]

166'-5" [50723.80]

124' [37795.20]

42'-5" [12928.60]